


OPTION-12

GROUND FLOOR PLAN


PROJECT PROPOSED LAYOUT OF PUNJAB & SIND BANK BRANCH AT BEGUM BRIDGE MEERUT	DRAWING CEILING LAYOUT	NORTH 	SCALE N.T.S. DATE NOV 2024	ARCHITECT MOHIT & ASSOCIATES ARCHITECTS, INTERIORS, ESTIMATORS, E-291 SEC-27 NOIDA 201301 MO. - 07428217659, 9582218092
---	----------------------------------	------------------	---	---

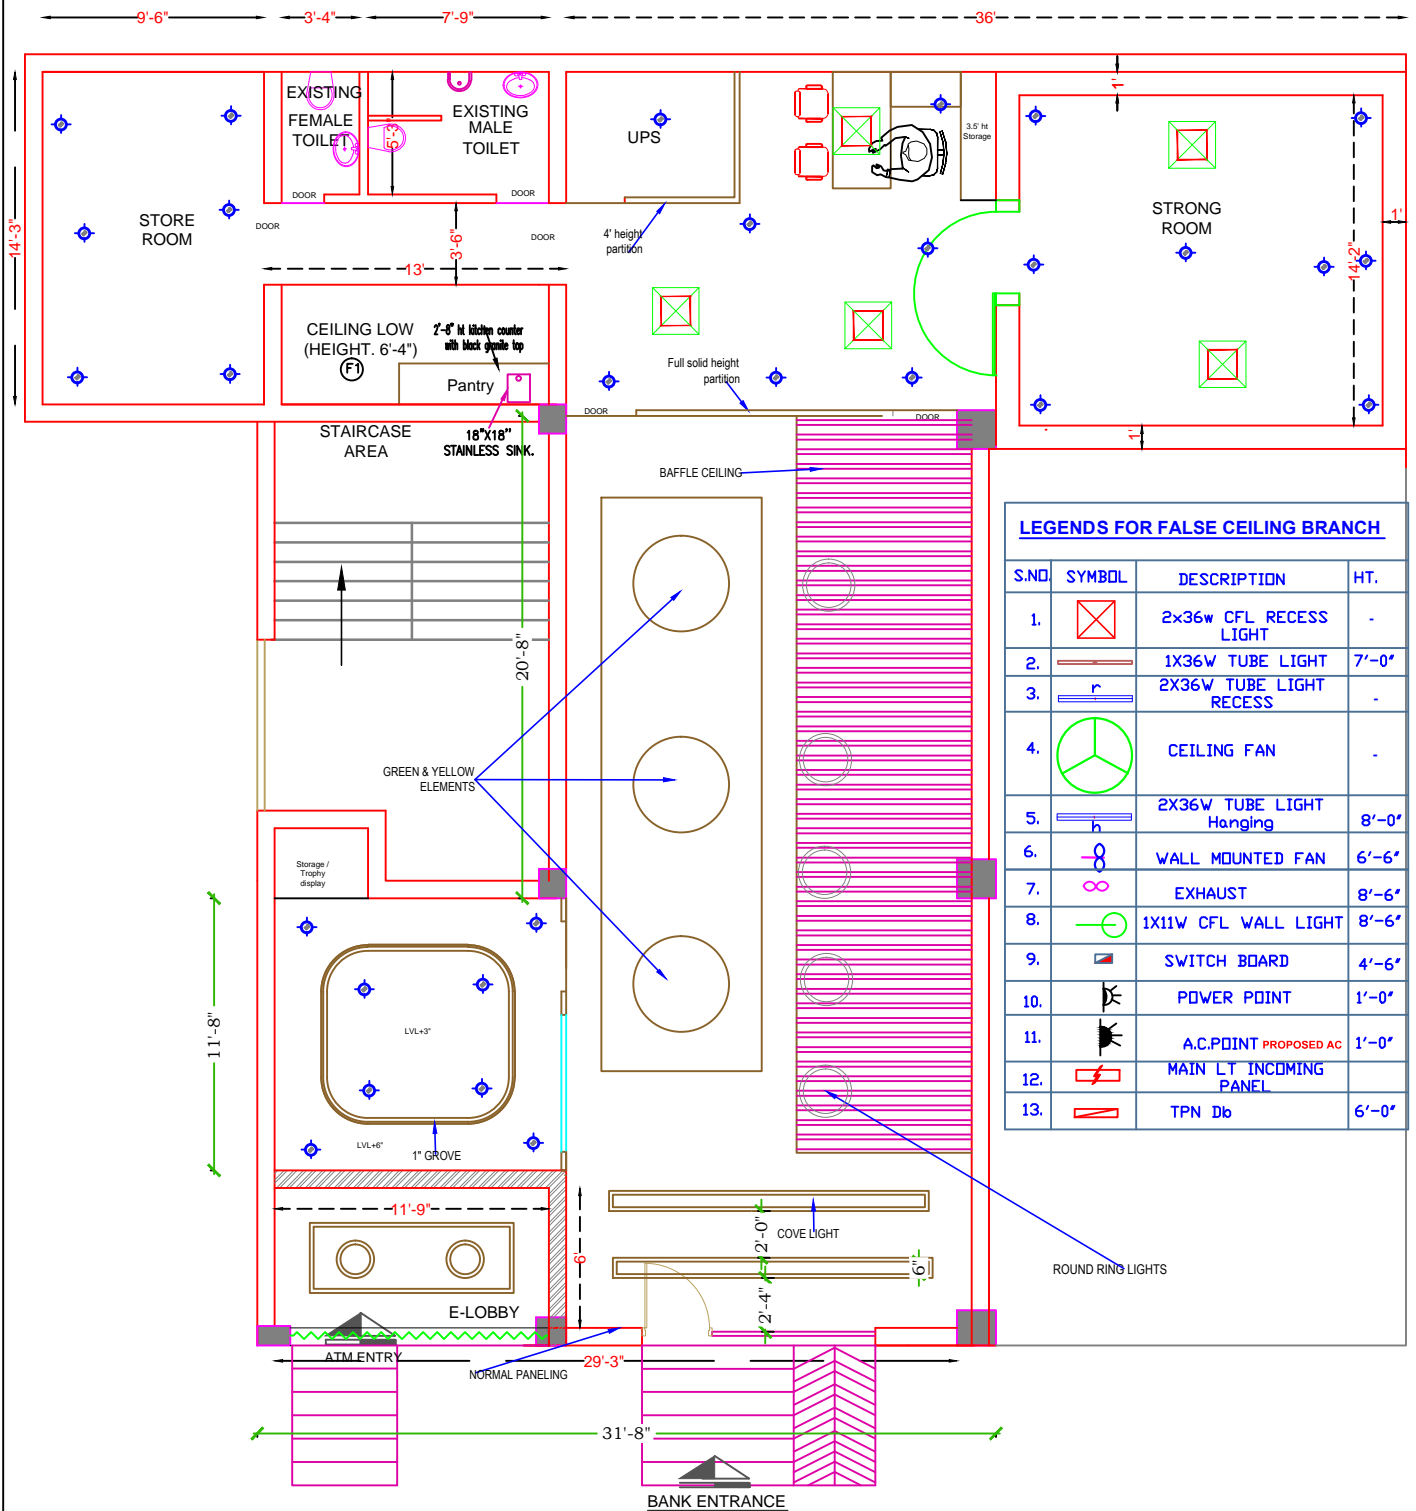

OPTION-12

GROUND FLOOR PLAN

PROJECT PROPOSED LAYOUT OF PUNJAB & SIND BANK BRANCH AT BEGUM BRIDGE MEERUT	DRAWING CEILING LAYOUT	NORTH 	SCALE N.T.S. DATE DEC 2024	ARCHITECT MOHIT & ASSOCIATES ARCHITECTS, INTERIORS, ESTIMATORS, E-291 SEC-27 NOIDA 201301 MO. - 07428217659, 9582218092
---	----------------------------------	------------------	---	---

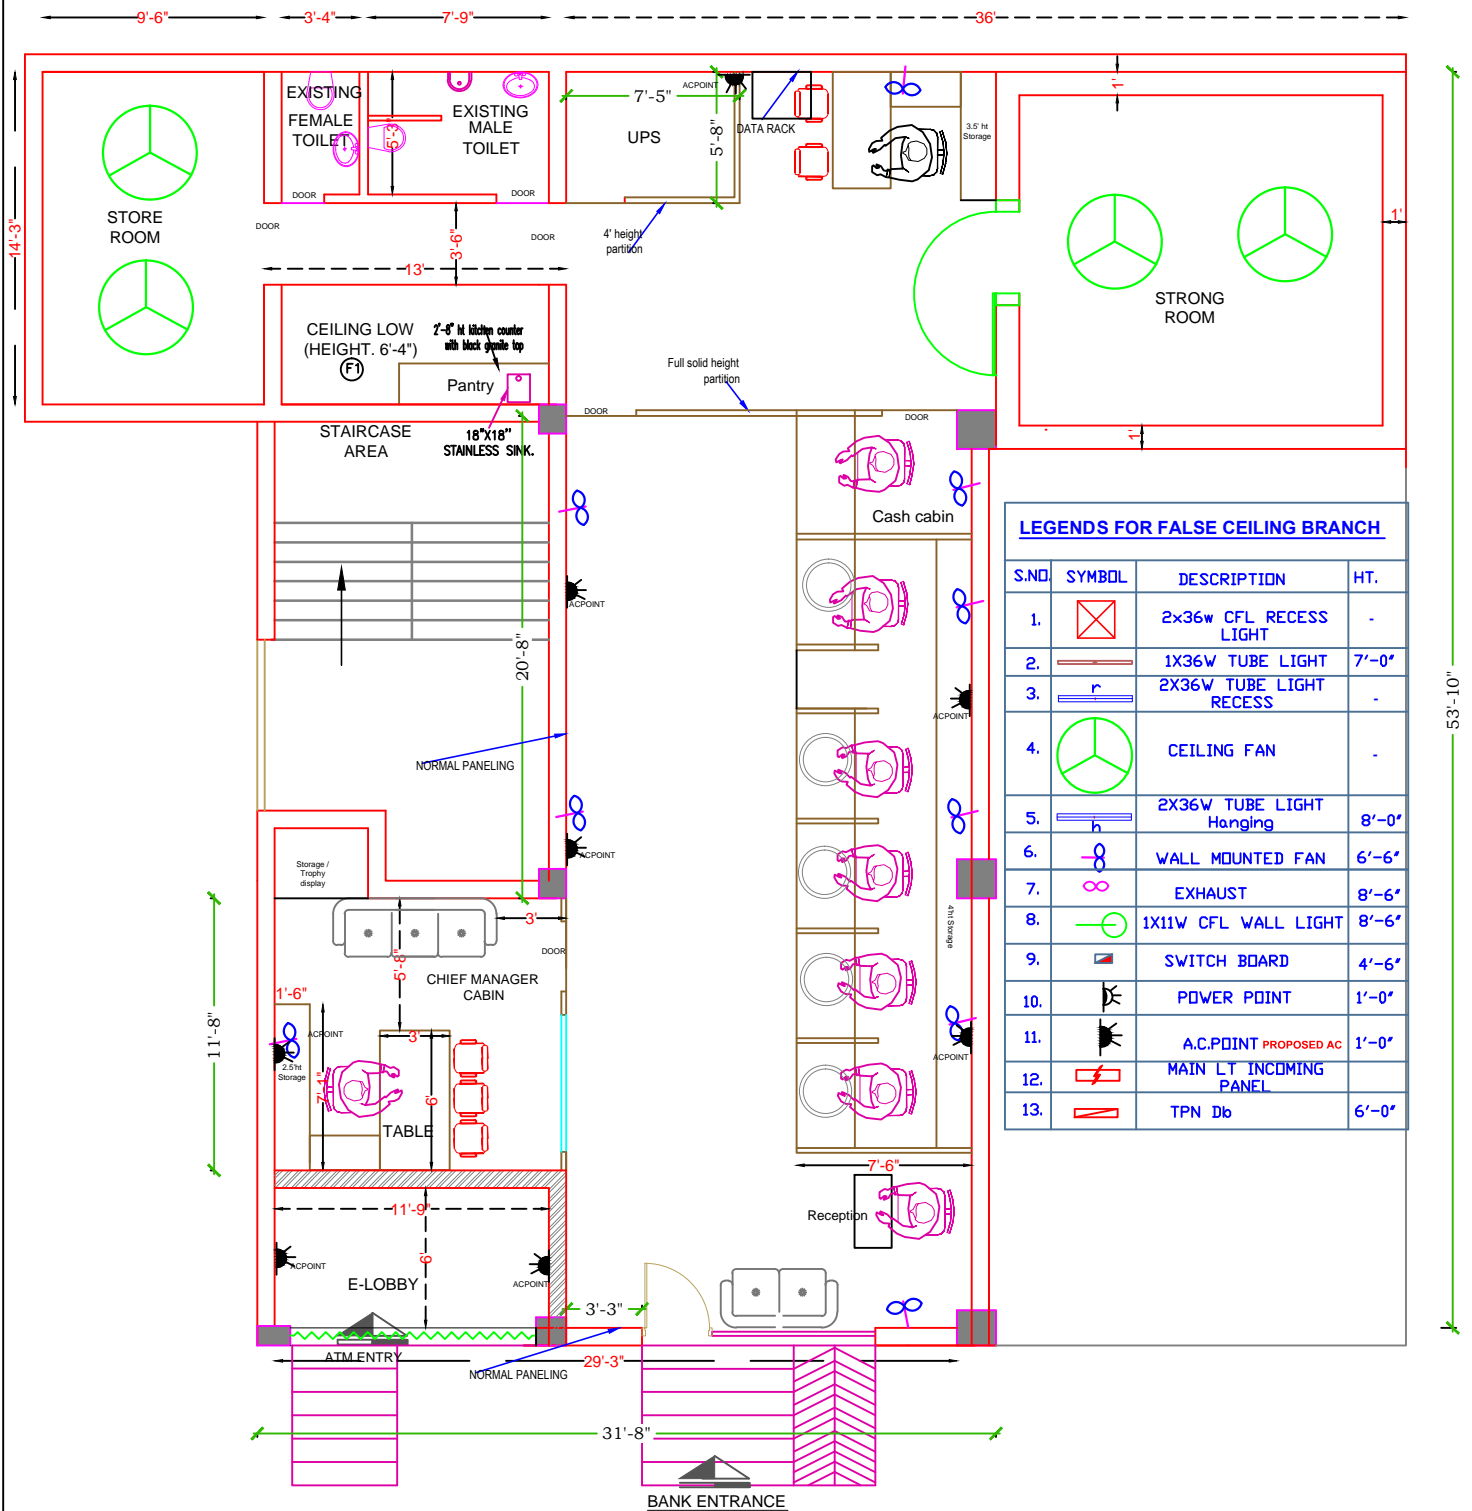


OPTION-12

GROUND FLOOR PLAN

PROJECT
PROPOSED LAYOUT OF PUNJAB & SIND BANK BRANCH AT
BEGUM BRIDGE MEERUT

 DRAWING
ELECTRICAL LAYOUT



SCALE
N.T.S.
DATE
DEC 2024

ARCHITECT
MOHIT & ASSOCIATES
ARCHITECTS, INTERIORS, ESTIMATORS,
E-291 SEC-27 NOIDA 201301
MO. - 07428217659, 9582218092